



CONRAIL  
 (F.K.A. CENTRAL RAILROAD OF NEW JERSEY - MAIN LINE)  
 (100' WIDE RIGHT-OF-WAY)

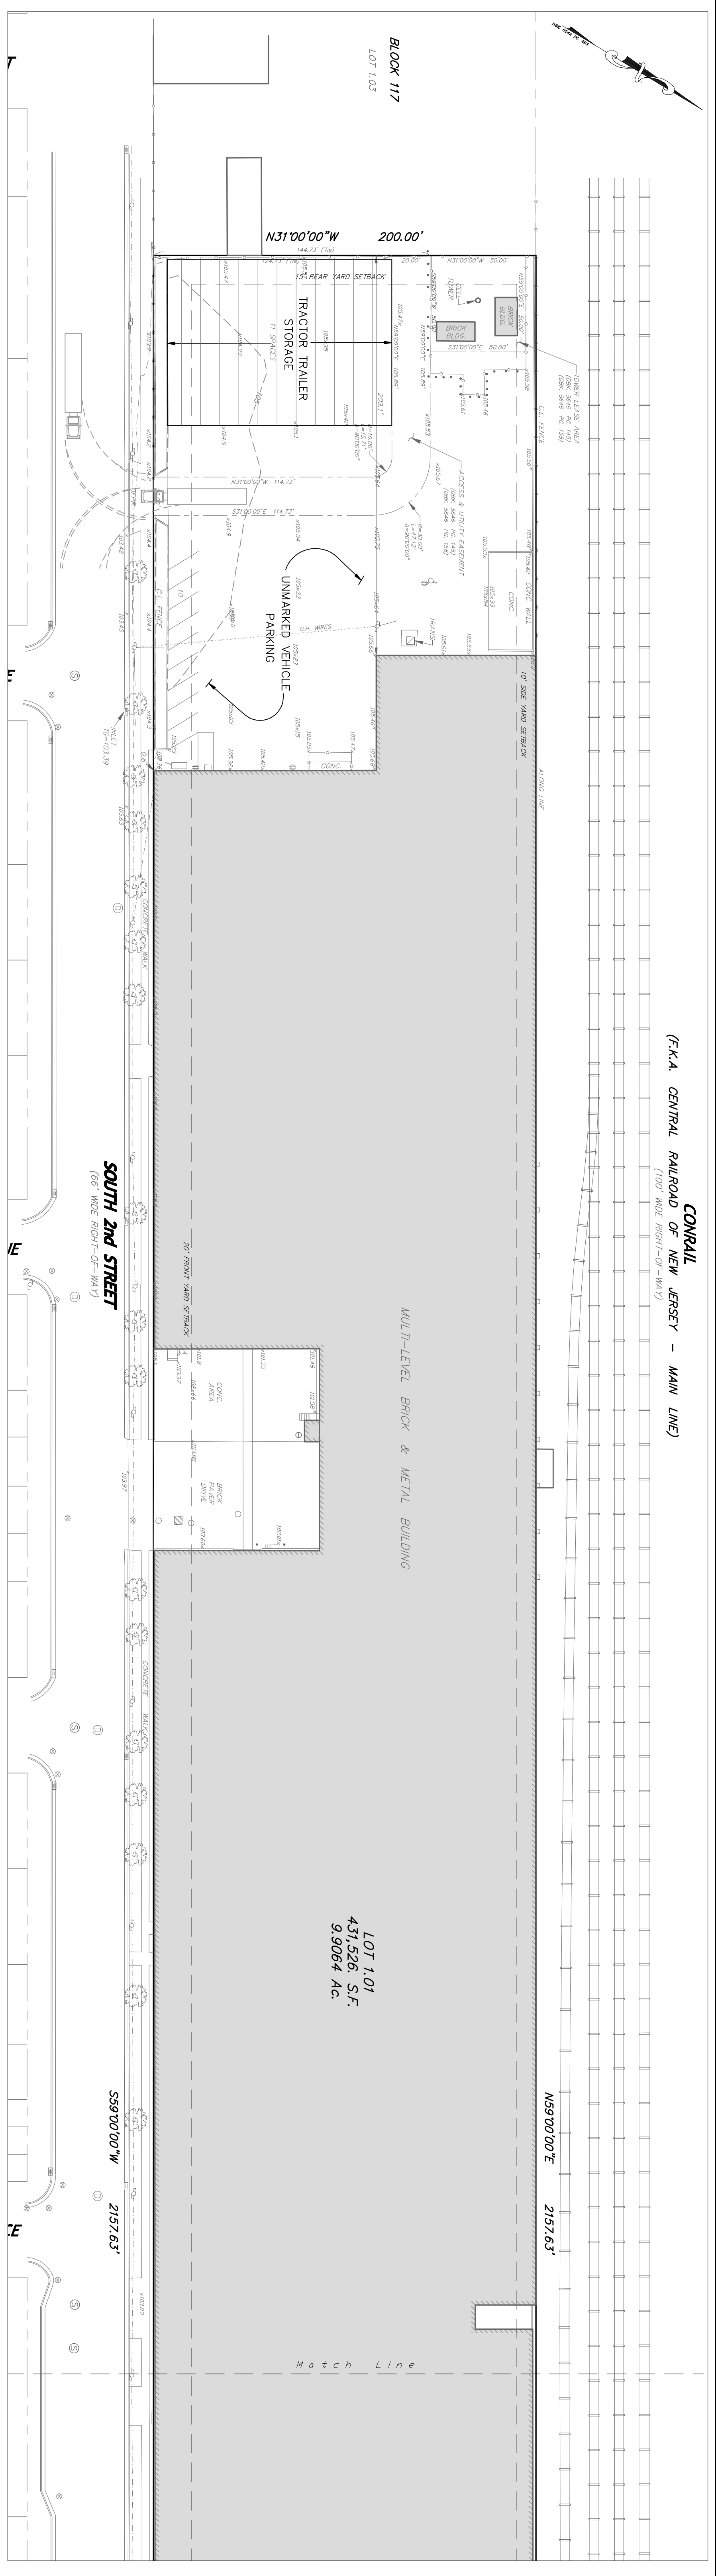


LOT 1.01  
 431,526 S.F.  
 9.9064 AC.

BLOCK 401  
 LOT 13  
 CONRAIL  
 (F.K.A. CENTRAL RAILROAD OF NEW JERSEY - MAIN LINE)  
 (100' WIDE RIGHT-OF-WAY)

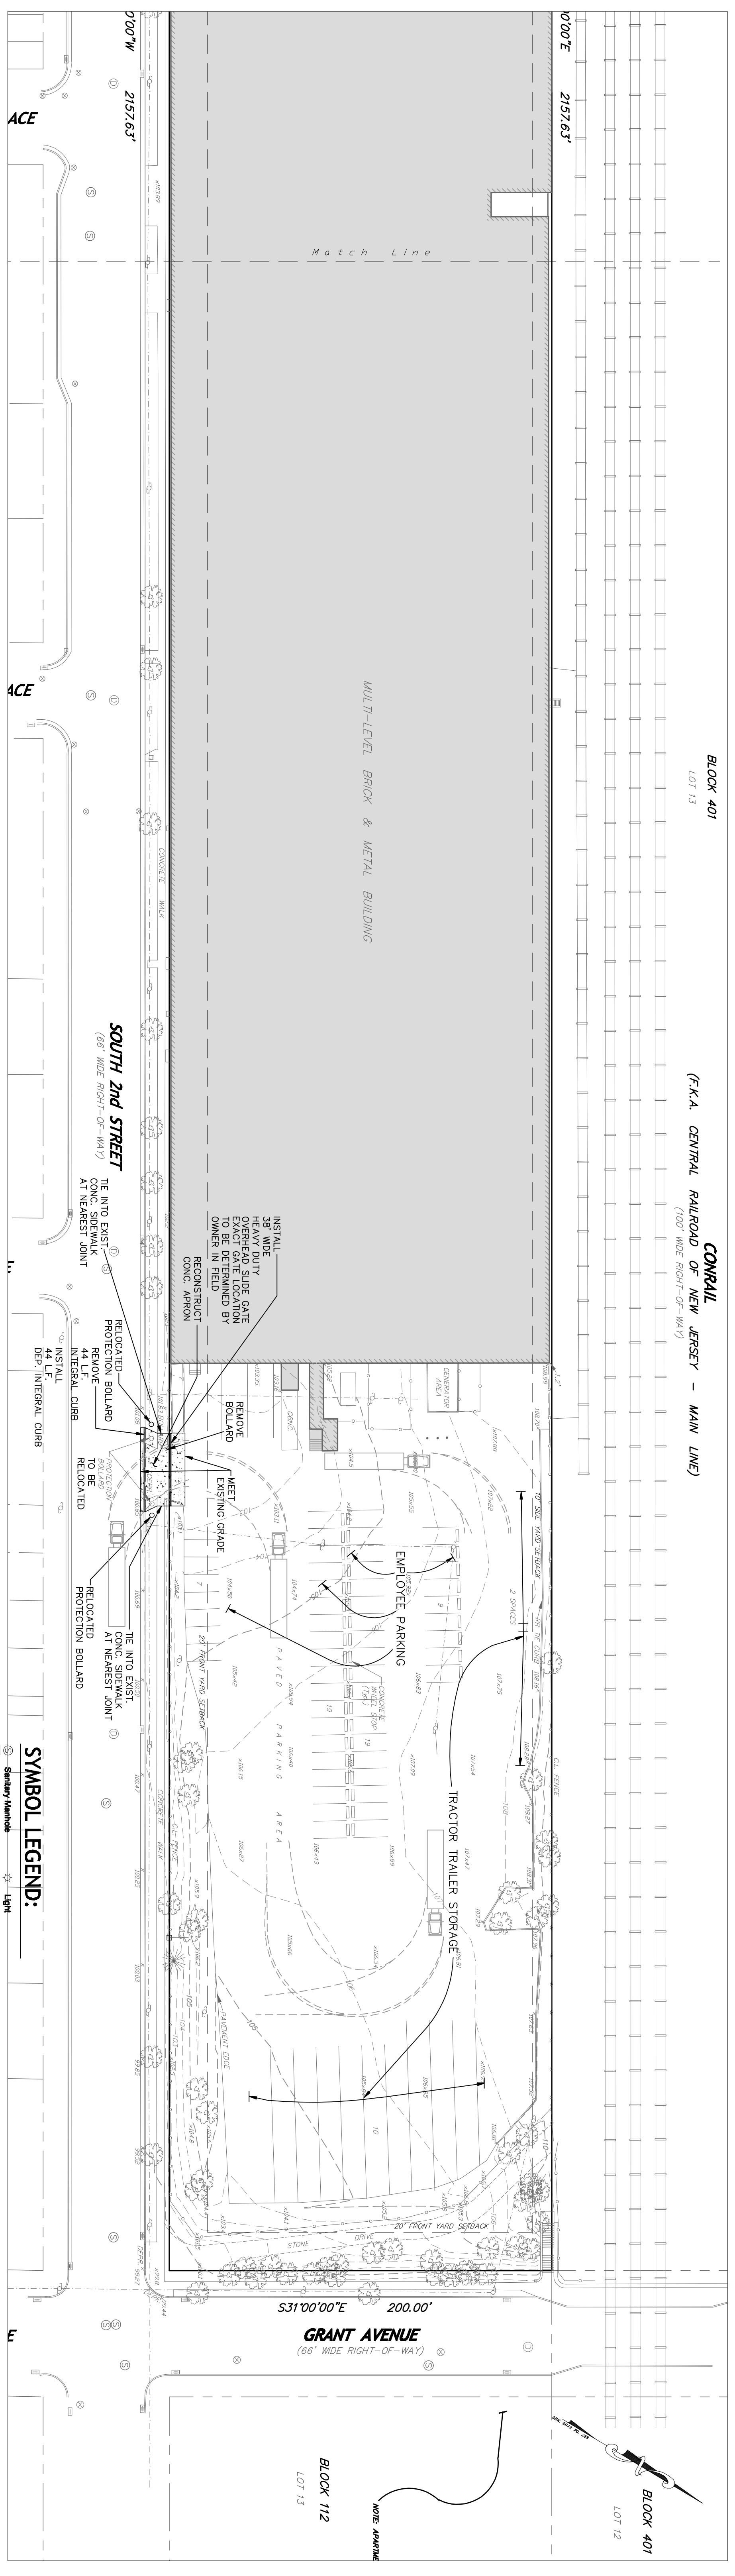

SYMBOL LEGEND:

- Sanitary Manhole
- Transformer
- Light
- Hydrant
- Electric Meter
- Gas Valve
- Water Valve
- Sign
- Sanitary Box
- Sanitary Churn
- Storm Manhole/Wall
- Type B Inlet
- Type A Inlet
- Monitoring Well
- Circle Inlet
- DOT
- Electric Meter
- Gas Valve
- Water Valve
- Light
- Hydrant
- Electric Meter
- Gas Valve
- Water Valve
- Sign
- Sanitary Box
- Sanitary Churn
- Storm Manhole/Wall
- Type B Inlet
- Type A Inlet
- Monitoring Well
- Circle Inlet

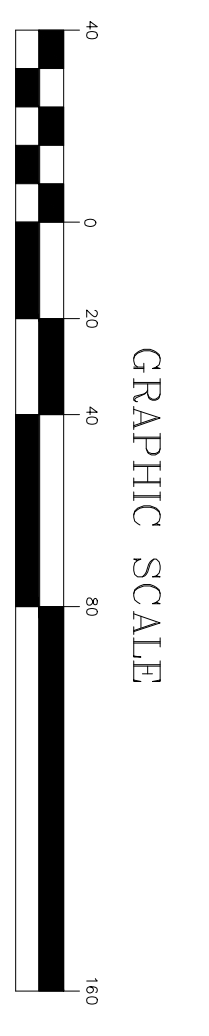

NOTICE  
 THIS PLAN AND ALL INFORMATION CONTAINED HEREIN IS UNLICENSED FOR THE STATE OF NEW JERSEY. NO PART OF THIS PLAN OR INFORMATION CONTAINED HEREIN IS TO BE REPRODUCED OR TRANSMITTED IN ANY FORM OR BY ANY MEANS, ELECTRONIC OR MECHANICAL, INCLUDING PHOTOCOPYING, RECORDING, OR BY ANY INFORMATION STORAGE AND RETRIEVAL SYSTEM, WITHOUT THE WRITTEN PERMISSION OF DAVID A. STIRES ASSOCIATES, LLC.

DATE	REVISION	BY
3/11/20	REVISED PER CITY COMMENTS	SMT
1/24/20	ADDED PROPOSED GATE	SMT

**DAS**  
 DAVID A. STIRES ASSOCIATES, LLC.  
 ENGINEERS - SURVEYORS - PLANNERS - ENVIRONMENTALISTS

678 US HWY 202/206 N, SUITE 6  
 BRIDGEWATER, N.J. 08807  
 PHONE: (908)252-7000 FAX: (908)252-7090

DAVID A. STIRES  
 PROFESSIONAL ENGINEER  
 N.J. LICENSE NO. 34814  
 DATE: 6/19/19

DESIGNED BY: DAS  
 DRAWN BY: SMT  
 CHECKED BY: DAS

SITE PLAN  
 1000 SOUTH SECOND STREET  
 TAX BLOCK 117 LOT 1.01  
 CITY OF PLAINFIELD UNION COUNTY NEW JERSEY

PROJECT NO. 19075  
 SHEET NUMBER 2 OF 3